

BILL OF MATERIAL					
NO OF LOTS: 56					
PITS			DUCTS		
SIZE	QTY	SIZE	QTY	MTRS	
2	5	P100	27	735.7	
5	14	P50	4	79.8	
8	6	P23	57	299	
9	0				
TOTAL NUMBER OF PITS: 25					
TOTAL NUMBER OF CONDUITS: 88					
TOTAL LENGTH OF CONDUITS: 1114.5					


Development Information	
Development Name: THE VILLAGE	Developer Company: EDQ
Development Address: DARTER STREET, OONONBA, 4811	
Authorised Rep: TALLIS ASHLEY Phone: 0422 294 906 E-Mail: Tallis.Ashley@dsdp.qld.gov.au	
CRM ID: AYCA-2DDHYW	Stage Number: 10

PROJECT LEGEND:


- PAD MOUNT SUB-STATION
- FIBRE DISTRIBUTION HUB
- SERVICE DROP ACCESS PIT (SINGLE LID) (650mmX280mmX555mm)
- NETWORK BOUNDARY/LOCAL NETWORK PIT (SINGLE LID) (700mmX450mmX650mm)
- DISTRIBUTION/LOCAL NETWORK CONNECTION PIT (DOUBLE LID) (1360mmX555mmX860mm)
- FIBRE DISTRIBUTION HUB (FDH) CONNECTION PIT (TRIPLE LID) (1360mmX555mmX860mm)
- EXISTING NETWORK BOUNDARY/LOCAL NETWORK PIT (SINGLE LID) (700mmX450mmX650mm)
- PROPOSED CONDUIT
- EXISTING CONDUIT
- SHARED TRENCH
- DRIVEWAY ACCESS
- ZERO LOT BOUNDARY

NOTES:


- ALL NBN DRAWINGS SHALL BE READ IN CONJUNCTION WITH NBNCo. GUIDELINES, ALL RELEVANT ELECTRICAL AND CIVIL AND OTHER ENGINEERING DRAWINGS.
- WHERE CONDUITS BEND AROUND A STREET CORNER A PIT SHALL BE INSTALLED 3m FROM THE CORNER BOUNDARY PROPERTY. REFER TO DETAIL 1 WHERE THE CORNER BOUNDARY IS TRUNCATED.
- ALL PITS SHALL BE OFFSET 900mm FROM THE CENTRE LINE OF THE PIT TO THE PROPERTY BOUNDARY. REFER TO DETAIL 2.
- CONTRACTOR SHALL PROVIDE SPARE END CAPPED 100mm CONDUIT AT THE EXTENT OF STAGE BOUNDARIES FOR FUTURE STAGES.
- THE EDGE OF PIT SHALL OFFSET BETWEEN 900 - 1100mm FROM THE CENTRE LINE OF PILLAR AS PER DETAIL 3.
- PITS SHALL NOT BE INSTALLED IN DRIVEWAYS. DRIVEWAY LOCATIONS SHOWN BY ARROW OR REFER TO RELEVANT CIVIL DRAWINGS.
- REFER TO ELECTRICAL DRAWINGS FOR MINIMUM CLEARANCE DISTANCES BETWEEN TELECOMMUNICATIONS AND ELECTRICAL INFRASTRUCTURE.
- NBN PITS DRAWN OVERSIZE. REFER TO LEGEND FOR DETAILS ON PIT DIMENSIONS.
- CONDUIT LENGTHS ARE BASED ON DISTANCE TO THE CENTRE OF THE INSTALLED PIT.
- ALL ROAD CROSSINGS SHALL BE MARKED WITH KERB MARKERS.
- ALL CONSTRUCTION SHALL BE INSTALLED IN SHARED TRENCH UNLESS OTHERWISE SHOWN.

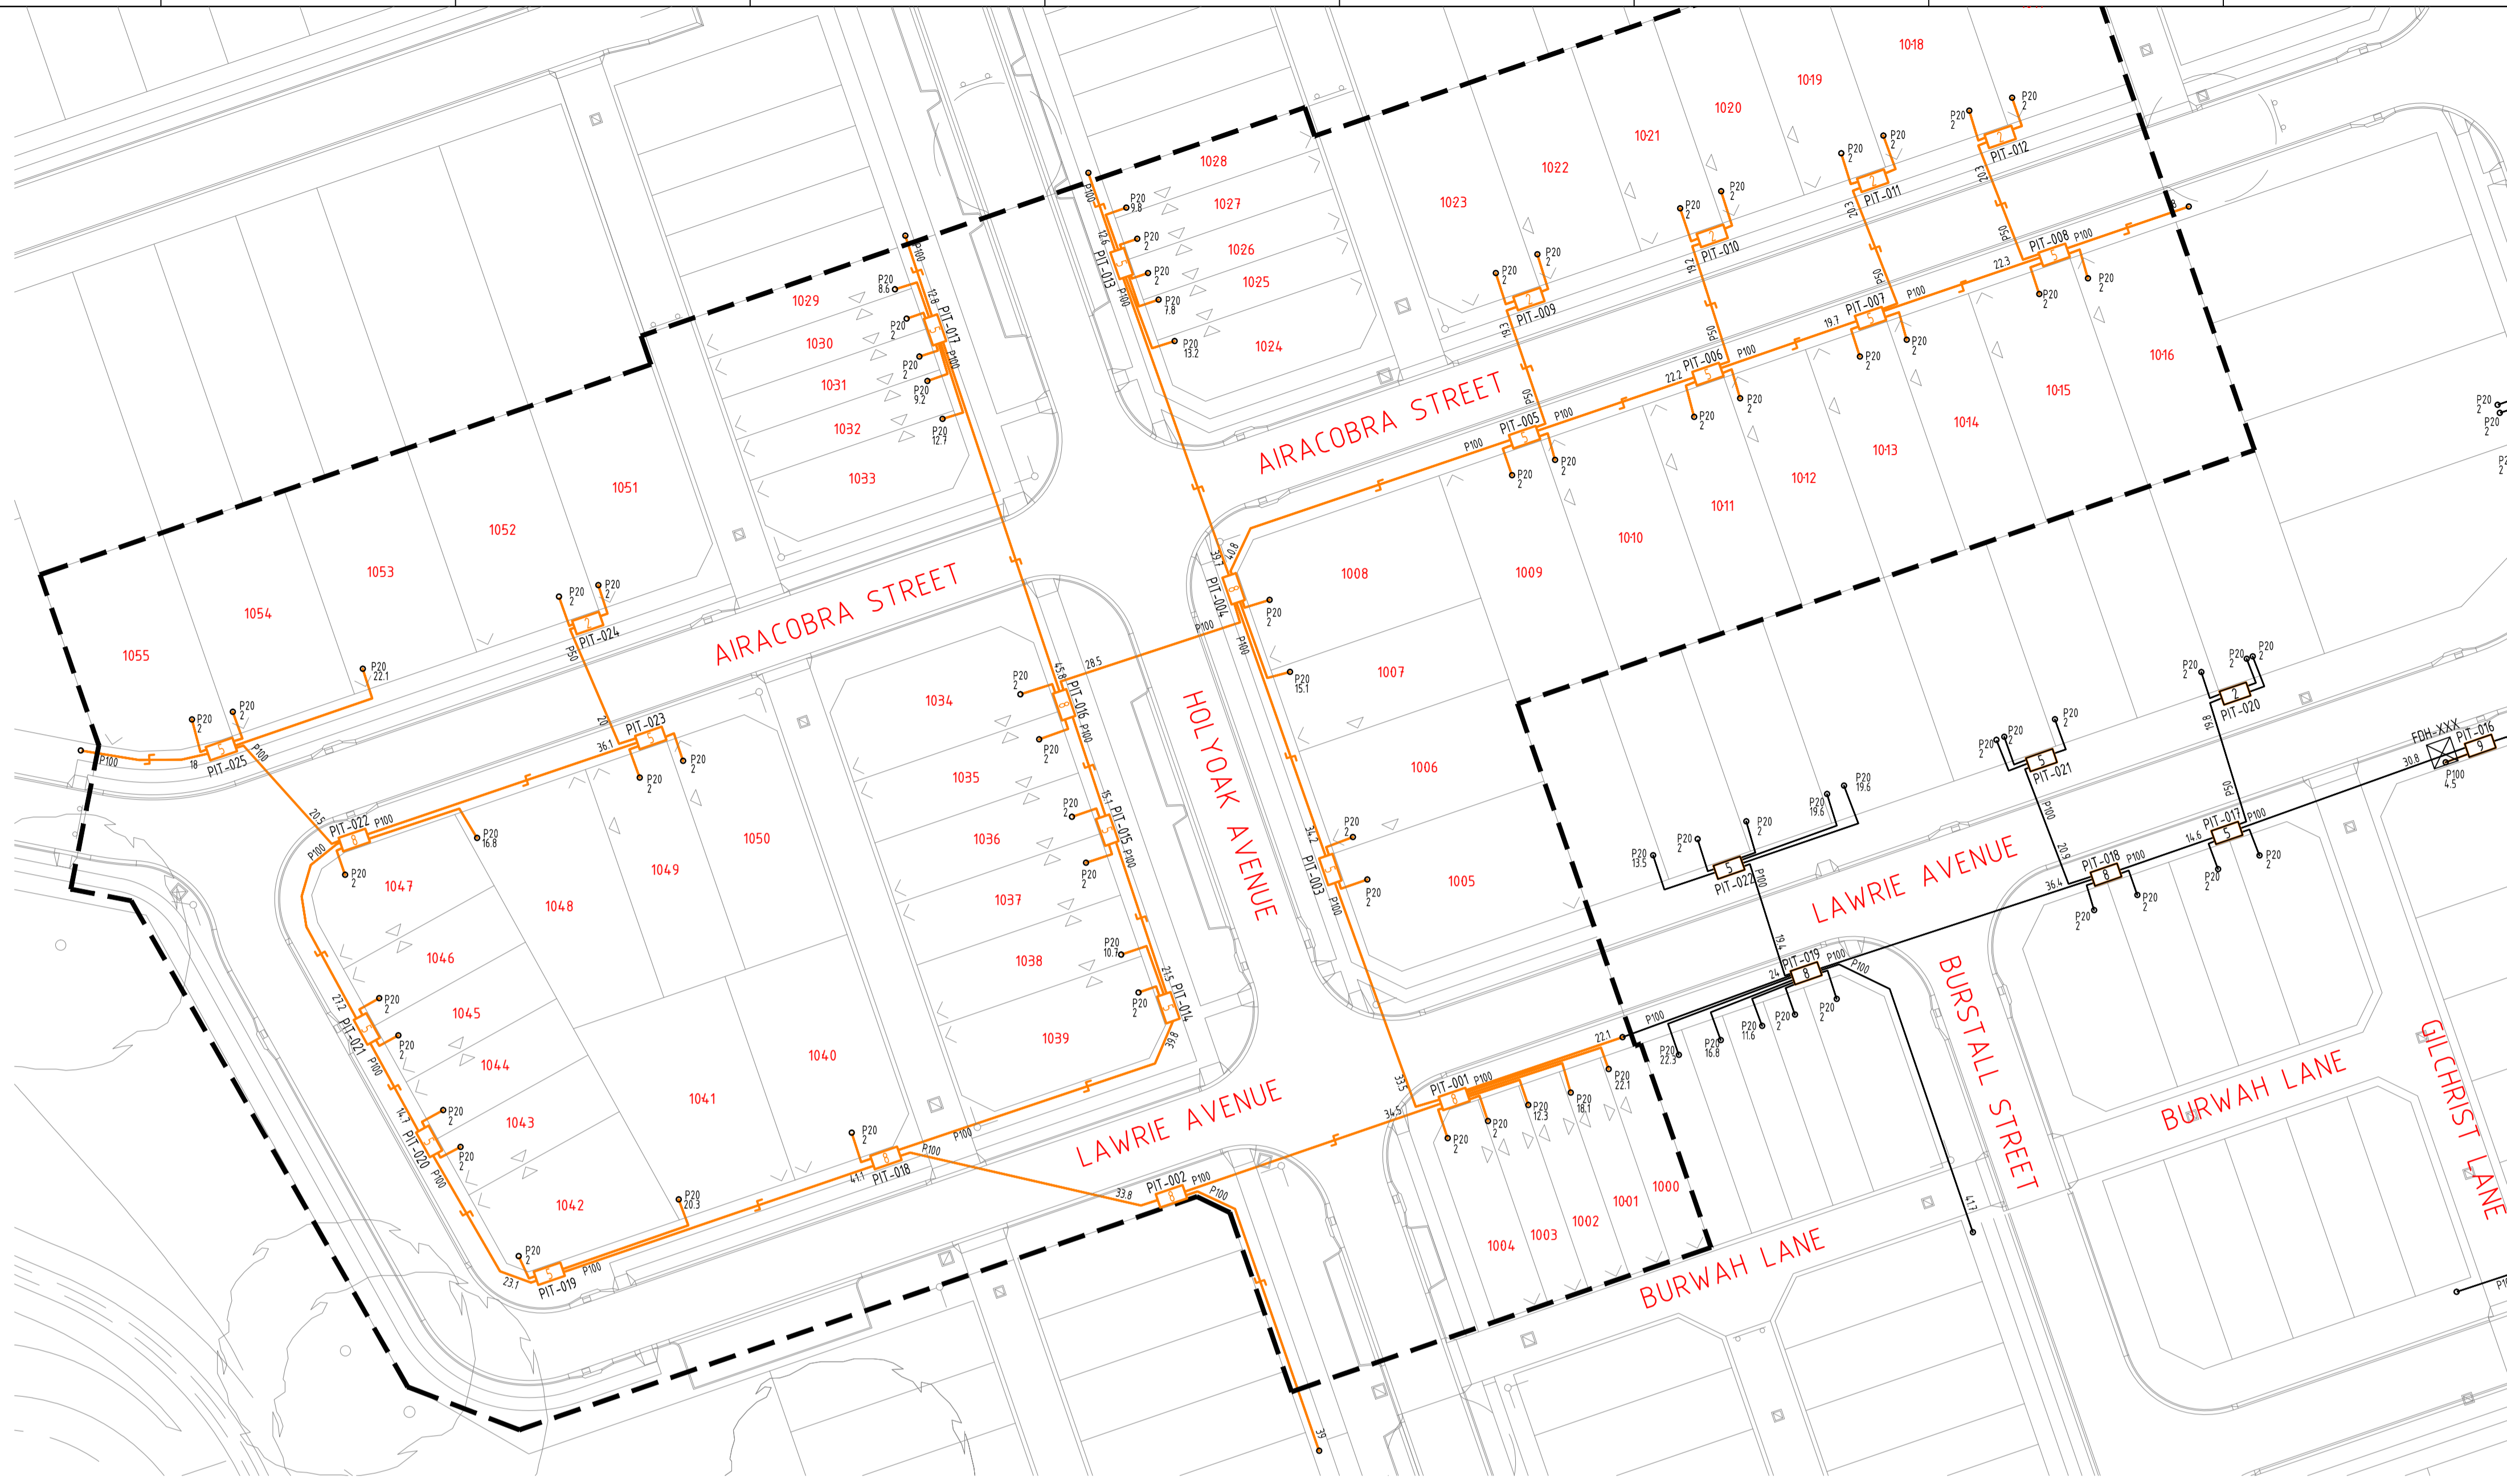


PARTIAL SITE PLAN: scale 1:500 @ A1

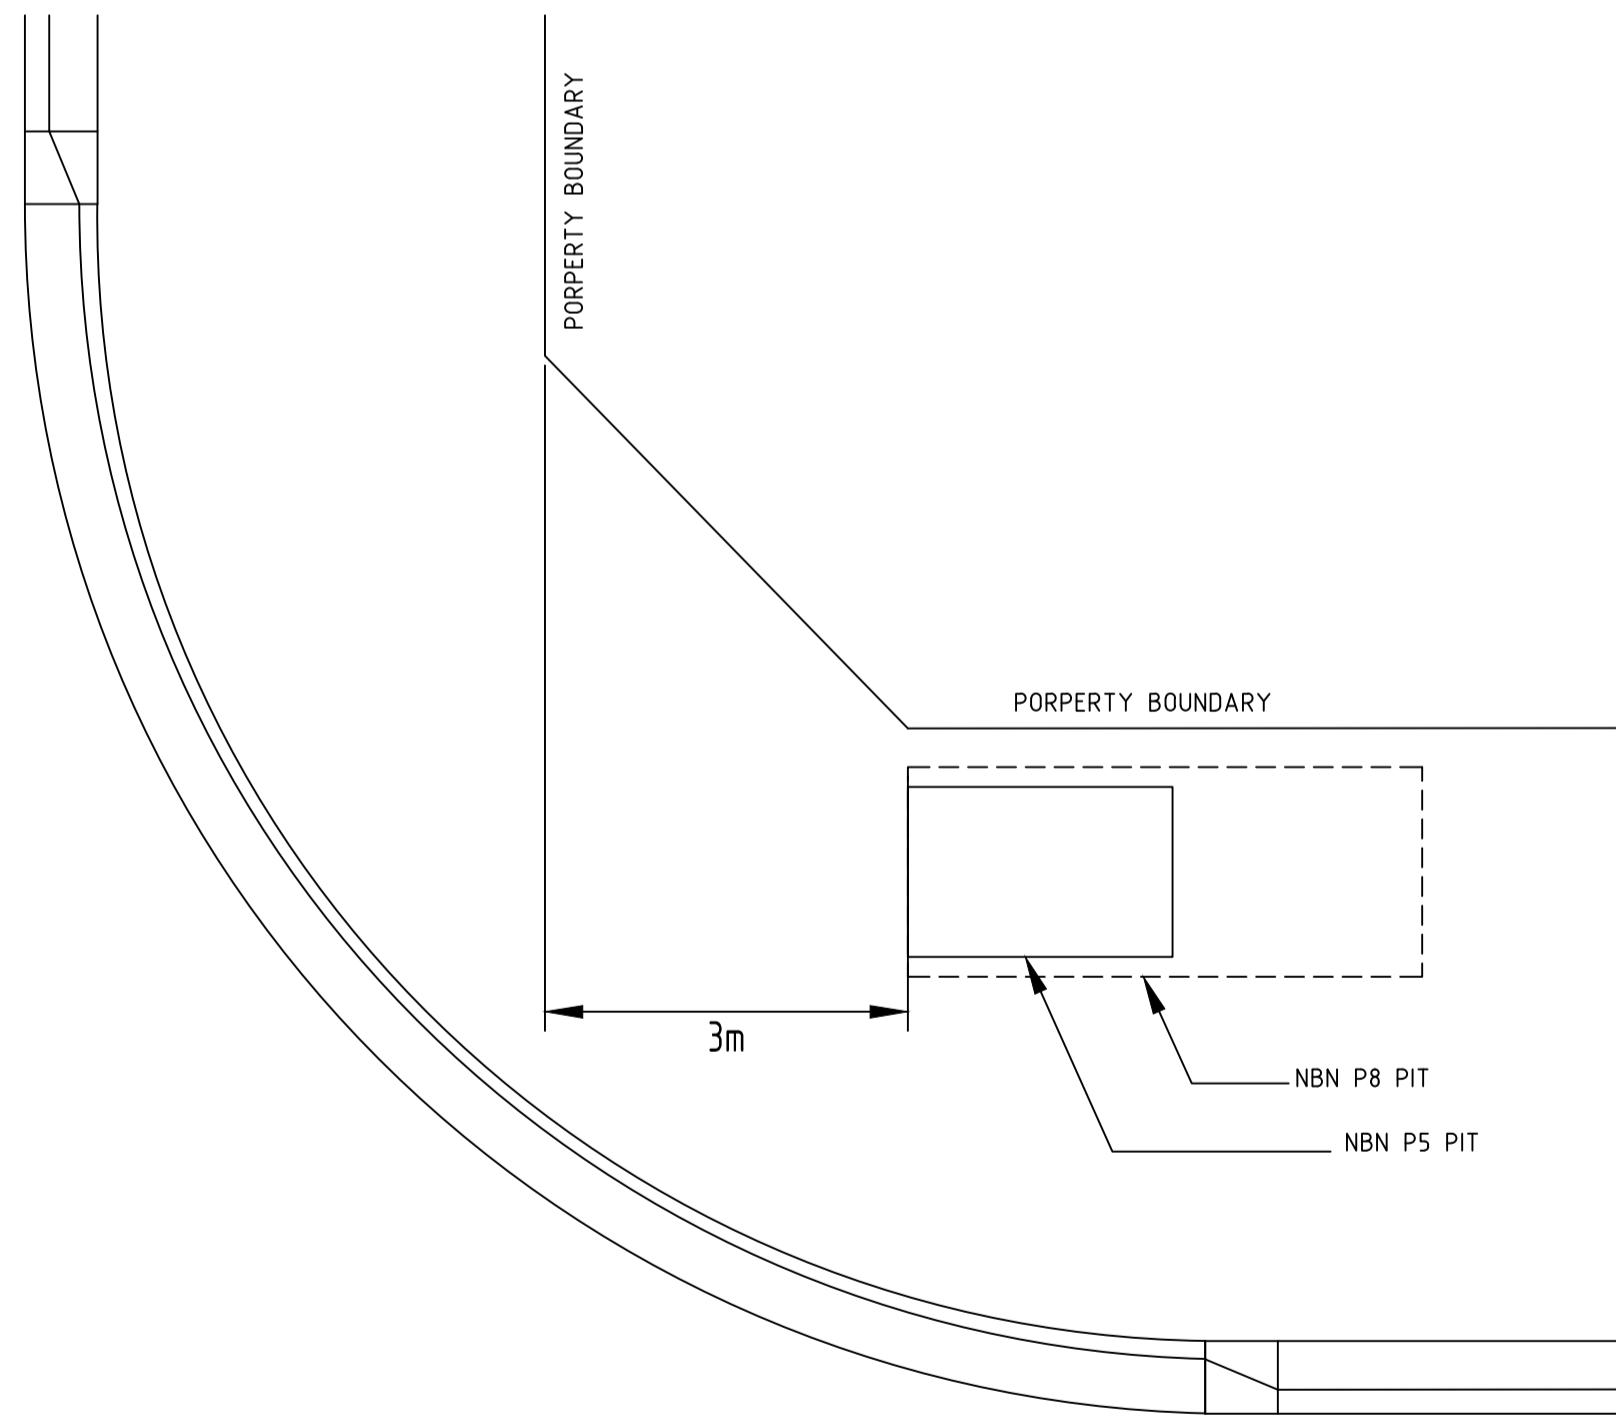

TRUNCATED CORNER OFFSET DETAIL No. 1: not to scale

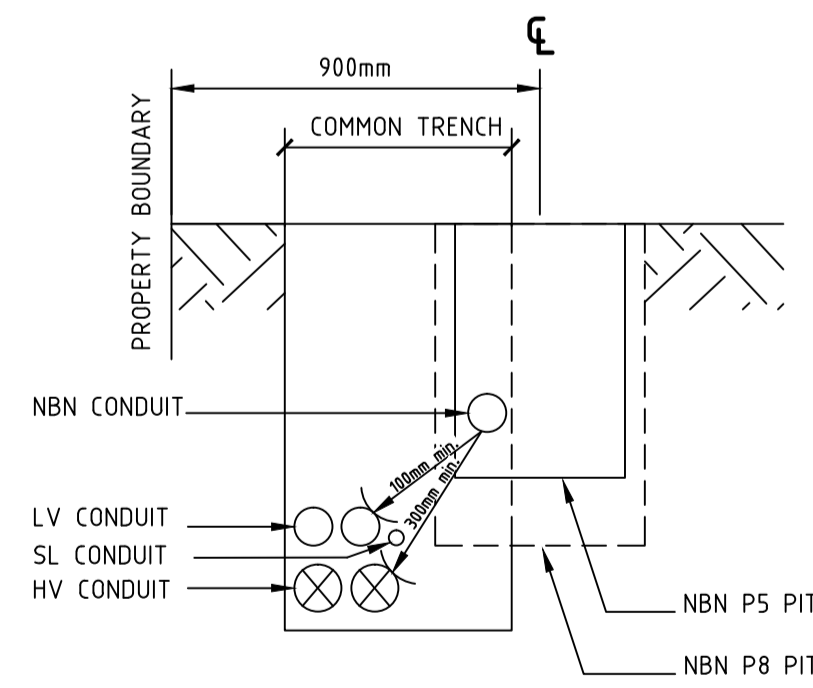

NBN PIT OFFSET DETAIL No. 2: not to scale

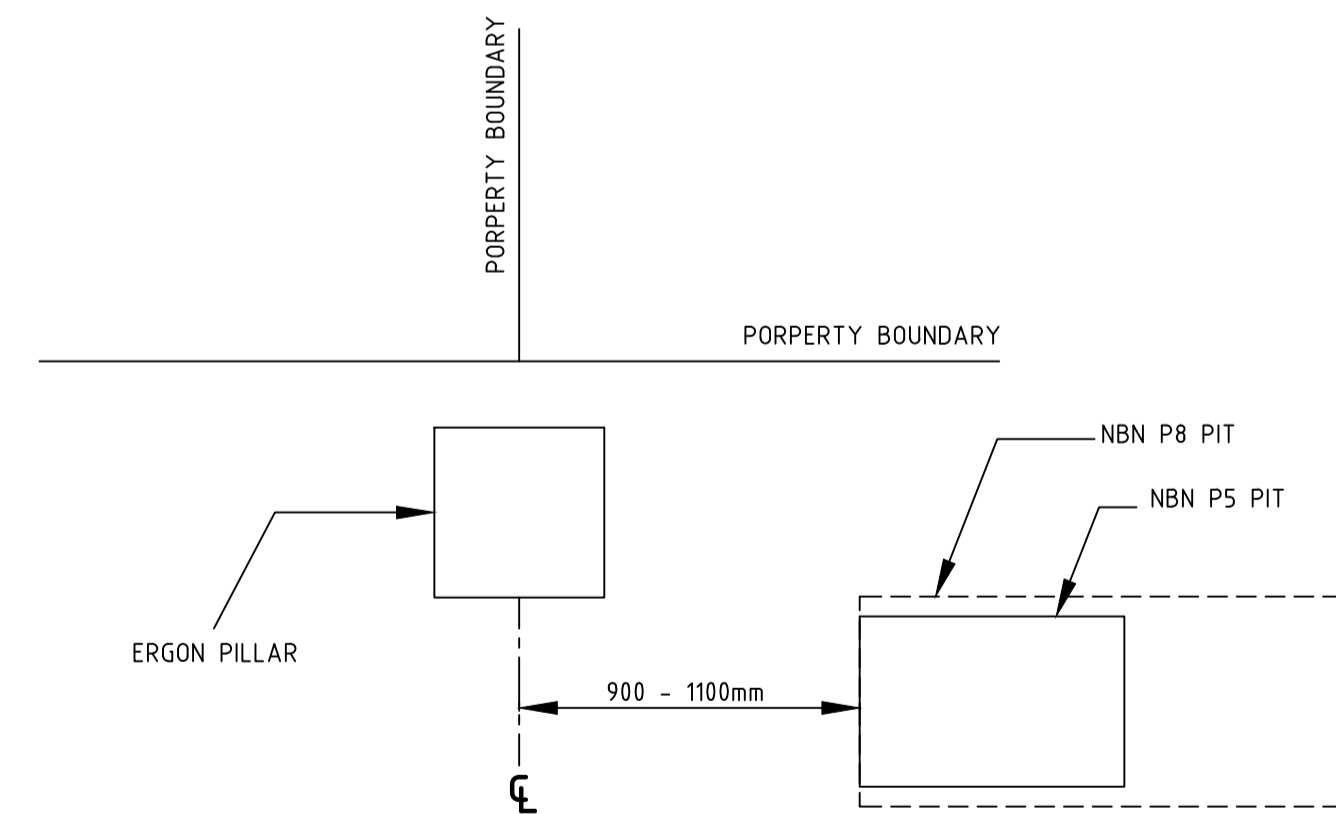

COMMON TRENCH ALIGNMENT DETAIL No. 3: not to scale

****ATTENTION****
CONSTRUCTORS DO NOT
 change or alter job
 specifications unless first
 checking with designer.

REV	DATE	DRAFTER	DESCRIPTION	APPROVED
A	11/08/2015	MATTHEW MORICONI	ORIGINAL ISSUE	TONY VAN HOMRIGH

NBNCO APPROVAL RECORD:	
SIGNATURE	DATE
<input type="checkbox"/> DD	_____
<input type="checkbox"/> WD	_____
<input type="checkbox"/> AB	_____

QUALITY RECORD :

NBNCO DISCLAIMER

THIS DOCUMENT HAS BEEN PREPARED SOLELY FOR THE USE OF NBNCO LIMITED (ABN 86 136 533 741) FOR USE IN MAINTAINING NBNCO FACILITIES. IT HAS NOT BEEN CREATED FOR ANY OTHER USE. IT SHOULD NOT BE SCALED TO LOCATE NBNCO ASSETS. NO WARRANTY IS GIVEN THAT THE INFORMATION IS ACCURATE OR COMPLETE.

Ashburner Francis consulting engineers

ASHBURNER FRANCIS PTY LTD (A.B.N. 48 009 975 197)

■ TOWNSVILLE
 ■ BRISBANE
 ■ TOWNSVILLE
 ■ DARWIN
 ■ PERTH
 ■ CAIRNS

KEY PLAN

DRAWING TITLE:		
THE VILLAGE STAGE 5 NBN PIT AND PIPE DESIGN		
STATE: QLD	REGION: NQ	
FSA: _____	FSAM: _____	FDA: _____
PROJECT No: AYCA-2DDHYW		
CADREF No: 15-4-128 N01		
SCALE: 1:500	SHEET No: 1 OF 1	REV: A